

LEGEND

- ☉ SMOKE ALARM (INTERCONNECTED)
- ⊙ CARBON MONOXIDE DETECTOR
- FIRE EXTINGUISHER
- EXIT SIGN (ILLUMINATED)
- 🚪 EMERGENCY LIGHTING (WITH BATTERY)
- ☐ MECHANICAL VENTILATION

I Ron Rogan have reviewed and taken responsibility for the design activities. I am qualified, and the firm is registered, in the appropriate classes/ categories.

Ron Rogan
BCIN 21606

ROGAN HOME DESIGN
BCIN 31434


Rogan Home Design

Ron Rogan, MAATO
237 Bismark Drive
Cambridge Ontario
(519) 621-4696


4 HICKORY STREET, WATERLOO

EXISTING SECOND FLOOR PLAN

DATE: July/06	SCALE: 1/4"=1'-0"	PROJ. No. Hickory	DWG No. A3
------------------	----------------------	----------------------	----------------------

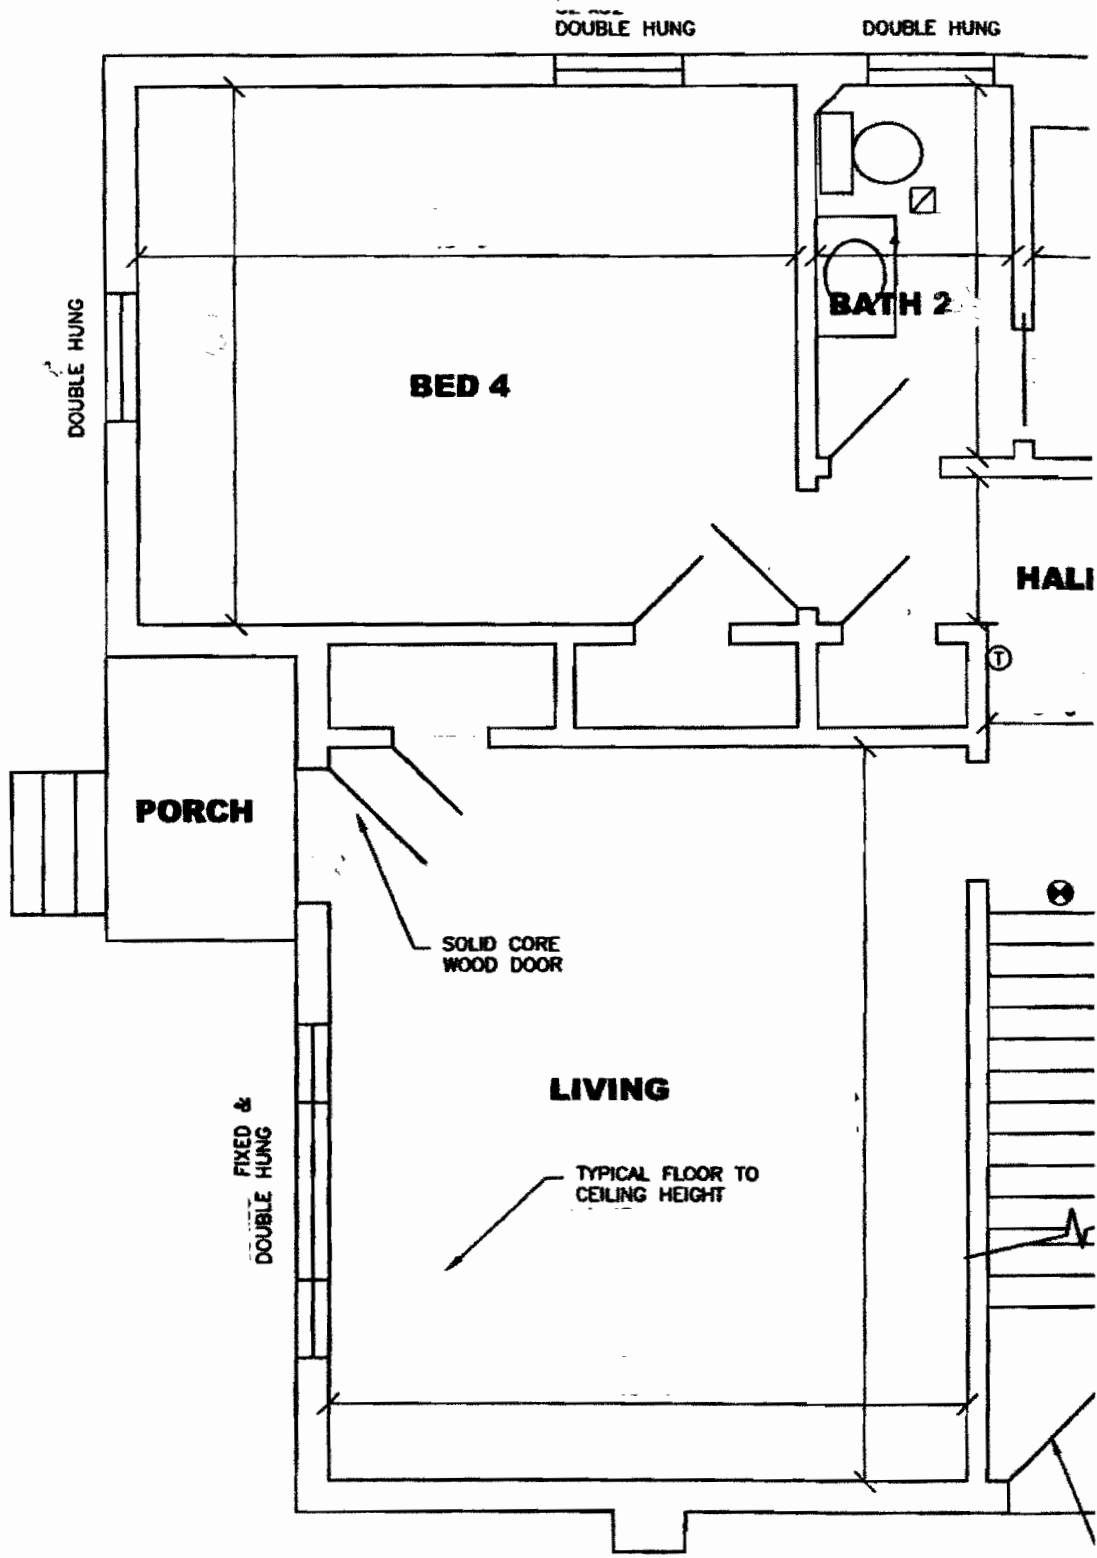

DOUBLE HUNG

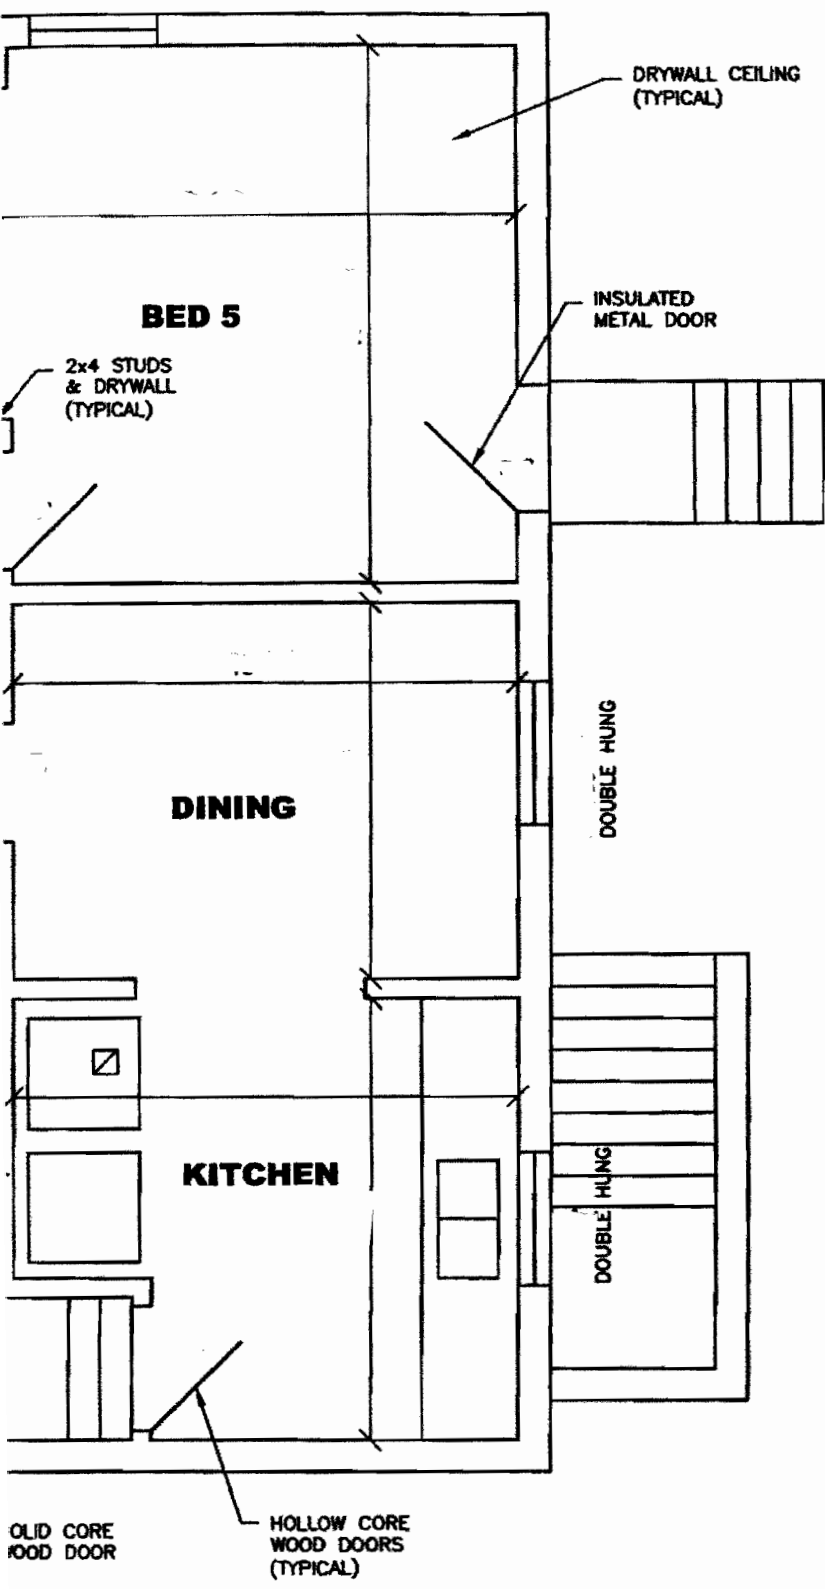

LEGEND

- ☉ SMOKE ALARM (INTERCONNECTED)
- ⊙ CARBON MONOXIDE DETECTOR
- FIRE EXTINGUISHER
- EXIT SIGN (ILLUMINATED)
- 🚪 EMERGENCY LIGHTING (WITH BATTERY)
- ☐ MECHANICAL VENTILATION

I Ron Rogan have reviewed and taken responsibility for the design activities. I am qualified, and the firm is registered, in the appropriate classes/ categories.

Ron Rogan
BCIN 21606

ROGAN HOME DESIGN
BCIN 31434


Rogan Home Design

Ron Rogan, MAATO
237 Bismark Drive
Cambridge Ontario
(519) 621-4696


4 HICKORY STREET, WATERLOO

EXISTING MAIN FLOOR PLAN

DATE: July/06	SCALE: 1/4"=1'-0"	PROJ. No. Hickory	DWG No. A2
------------------	----------------------	----------------------	----------------------

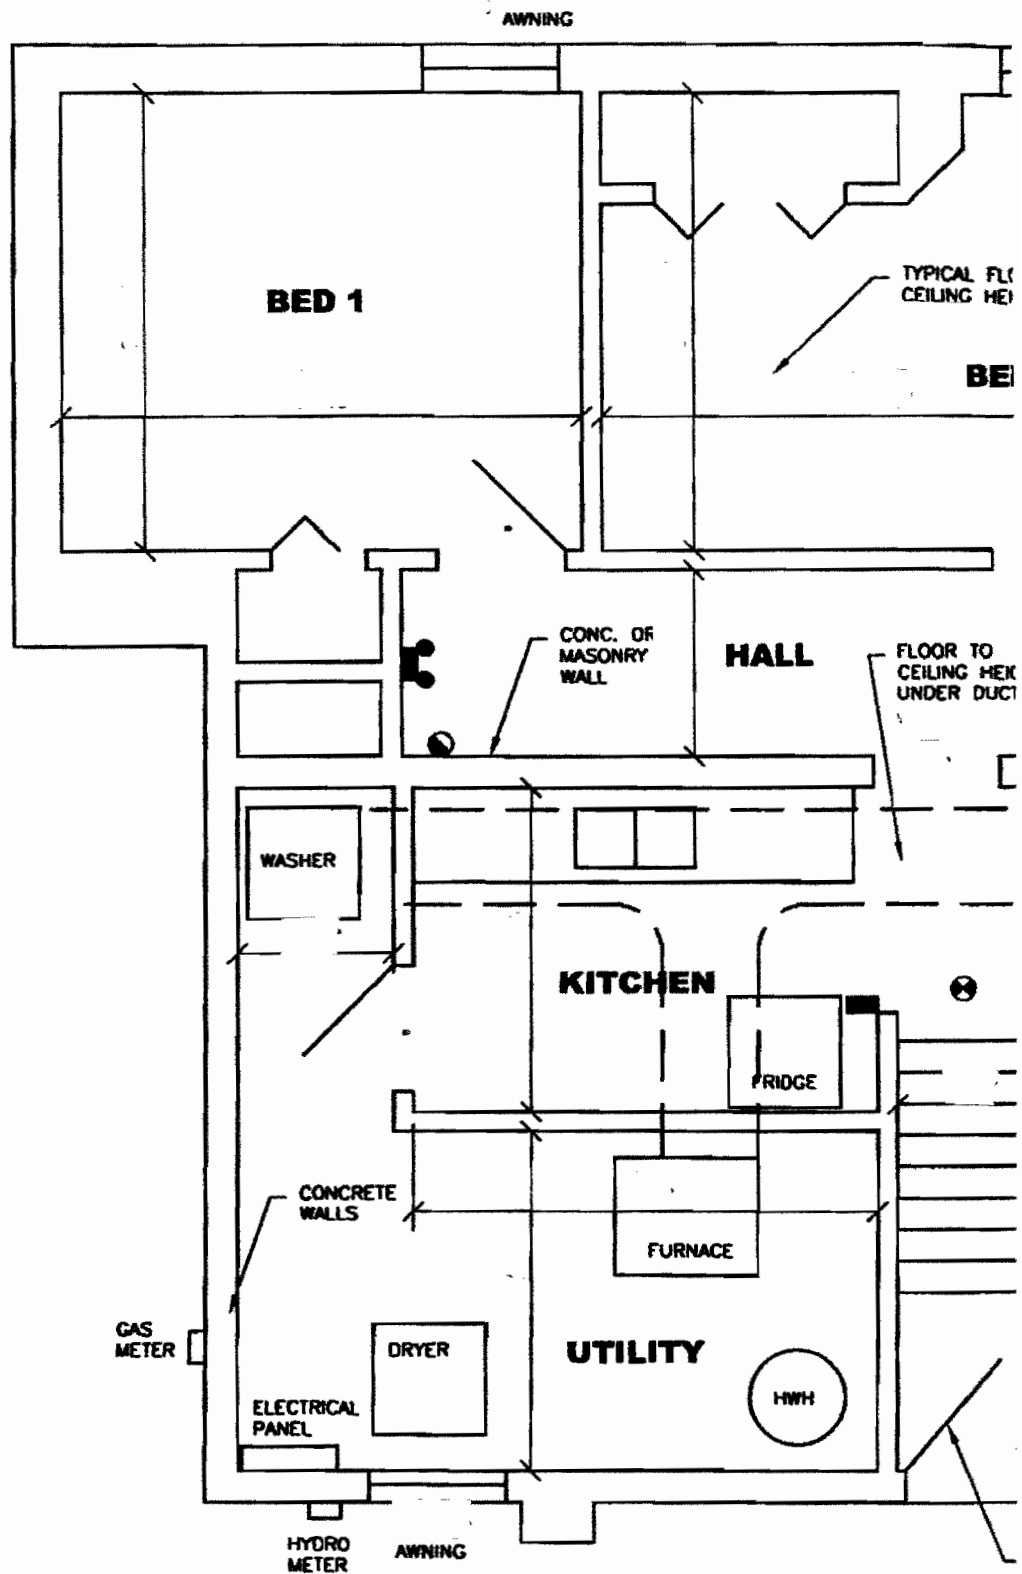

AWNING

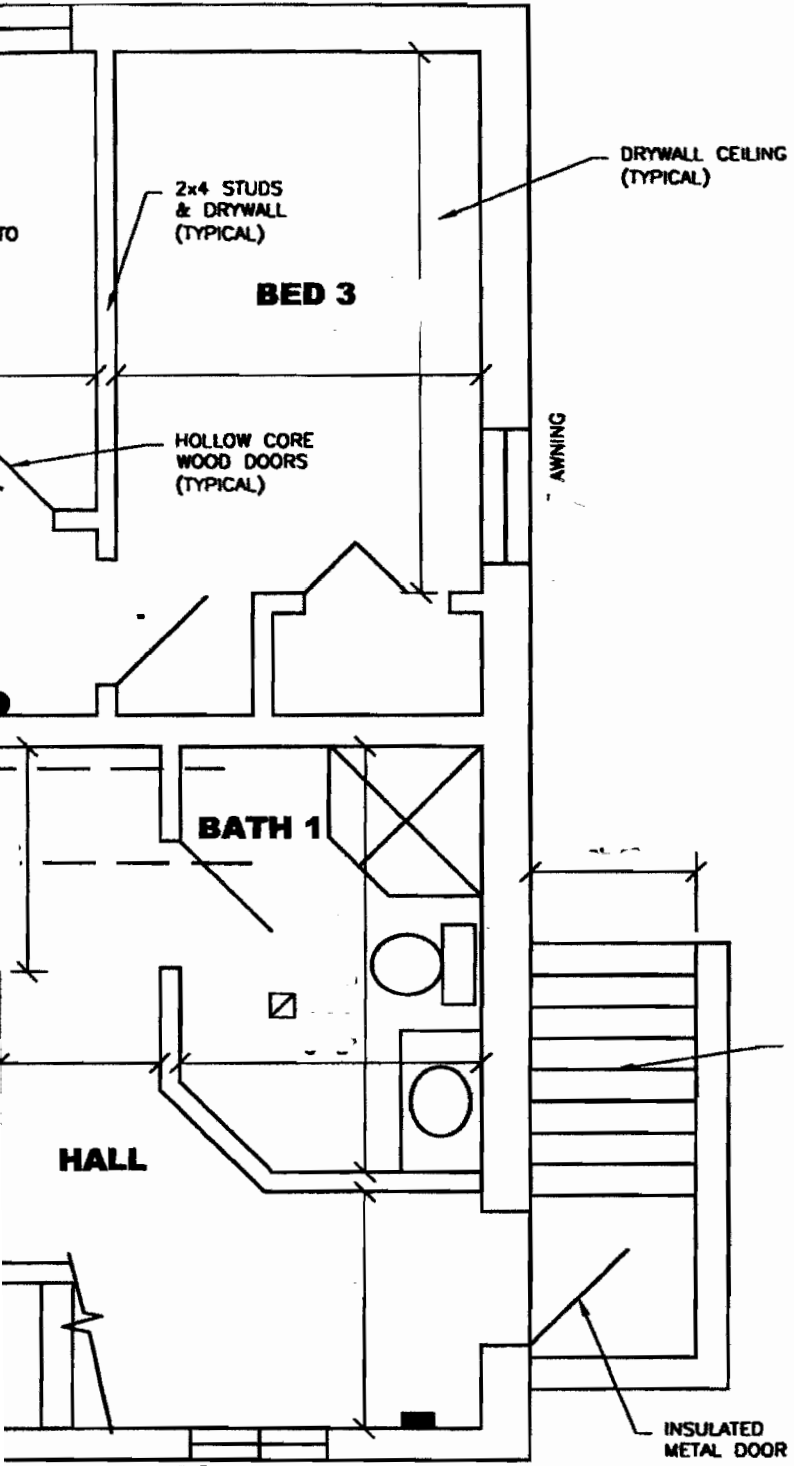

LEGEND

- ☉ SMOKE ALARM (INTERCONNECTED)
- ☉ CARBON MONOXIDE DETECTOR
- FIRE EXTINGUISHER
- EXIT SIGN (ILLUMINATED)
- ☼ EMERGENCY LIGHTING (WITH BATTERY)
- ☐ MECHANICAL VENTILATION

TO CORE
ID DOOR

I Ron Rogan have reviewed and taken responsibility for the design activities. I am qualified, and the firm is registered, in the appropriate classes/ categories.

Ron Rogan
BCIN 21606

ROGAN HOME DESIGN
BCIN 31434

Rogan Home Design

Ron Rogan, MAATO
237 Bismark Drive
Cambridge Ontario
(519) 621-4696

4 HICKORY STREET, WATERLOO

EXISTING BASEMENT FLOOR PLAN

DATE: July/06	SCALE: 1/4"=1'-0"	PROJ. No. Hickory	DWG No. A1
------------------	----------------------	----------------------	----------------------